




BASEMENT UNDERGROUND PIPING PLAN

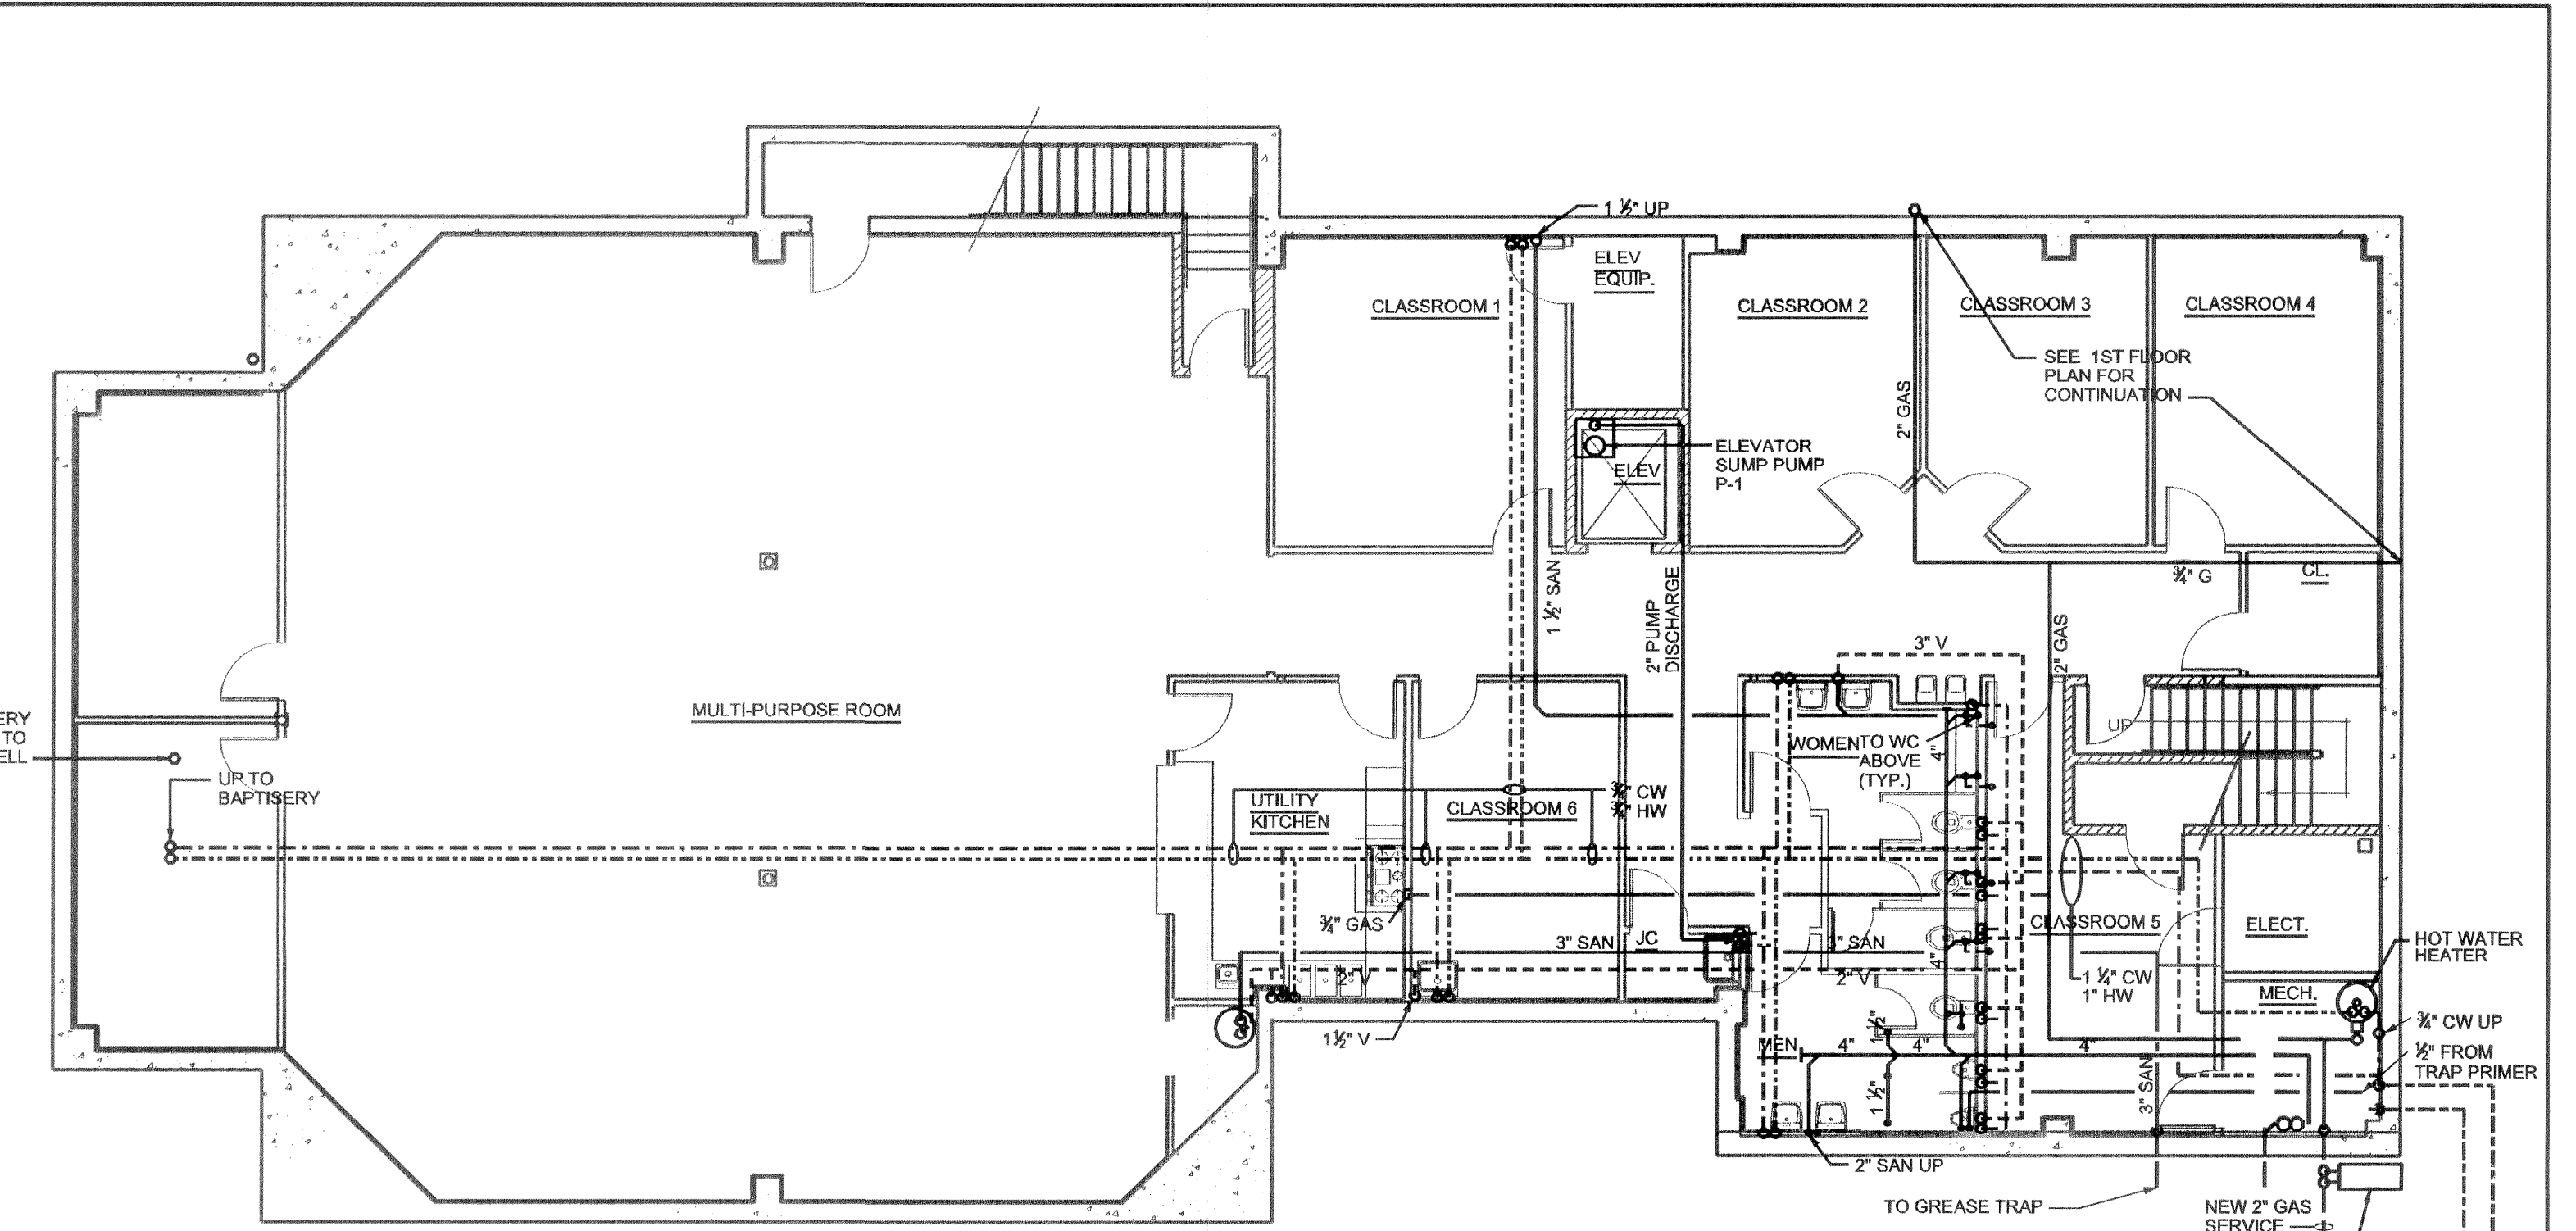

BASEMENT ABOVE GROUND PIPING PLAN

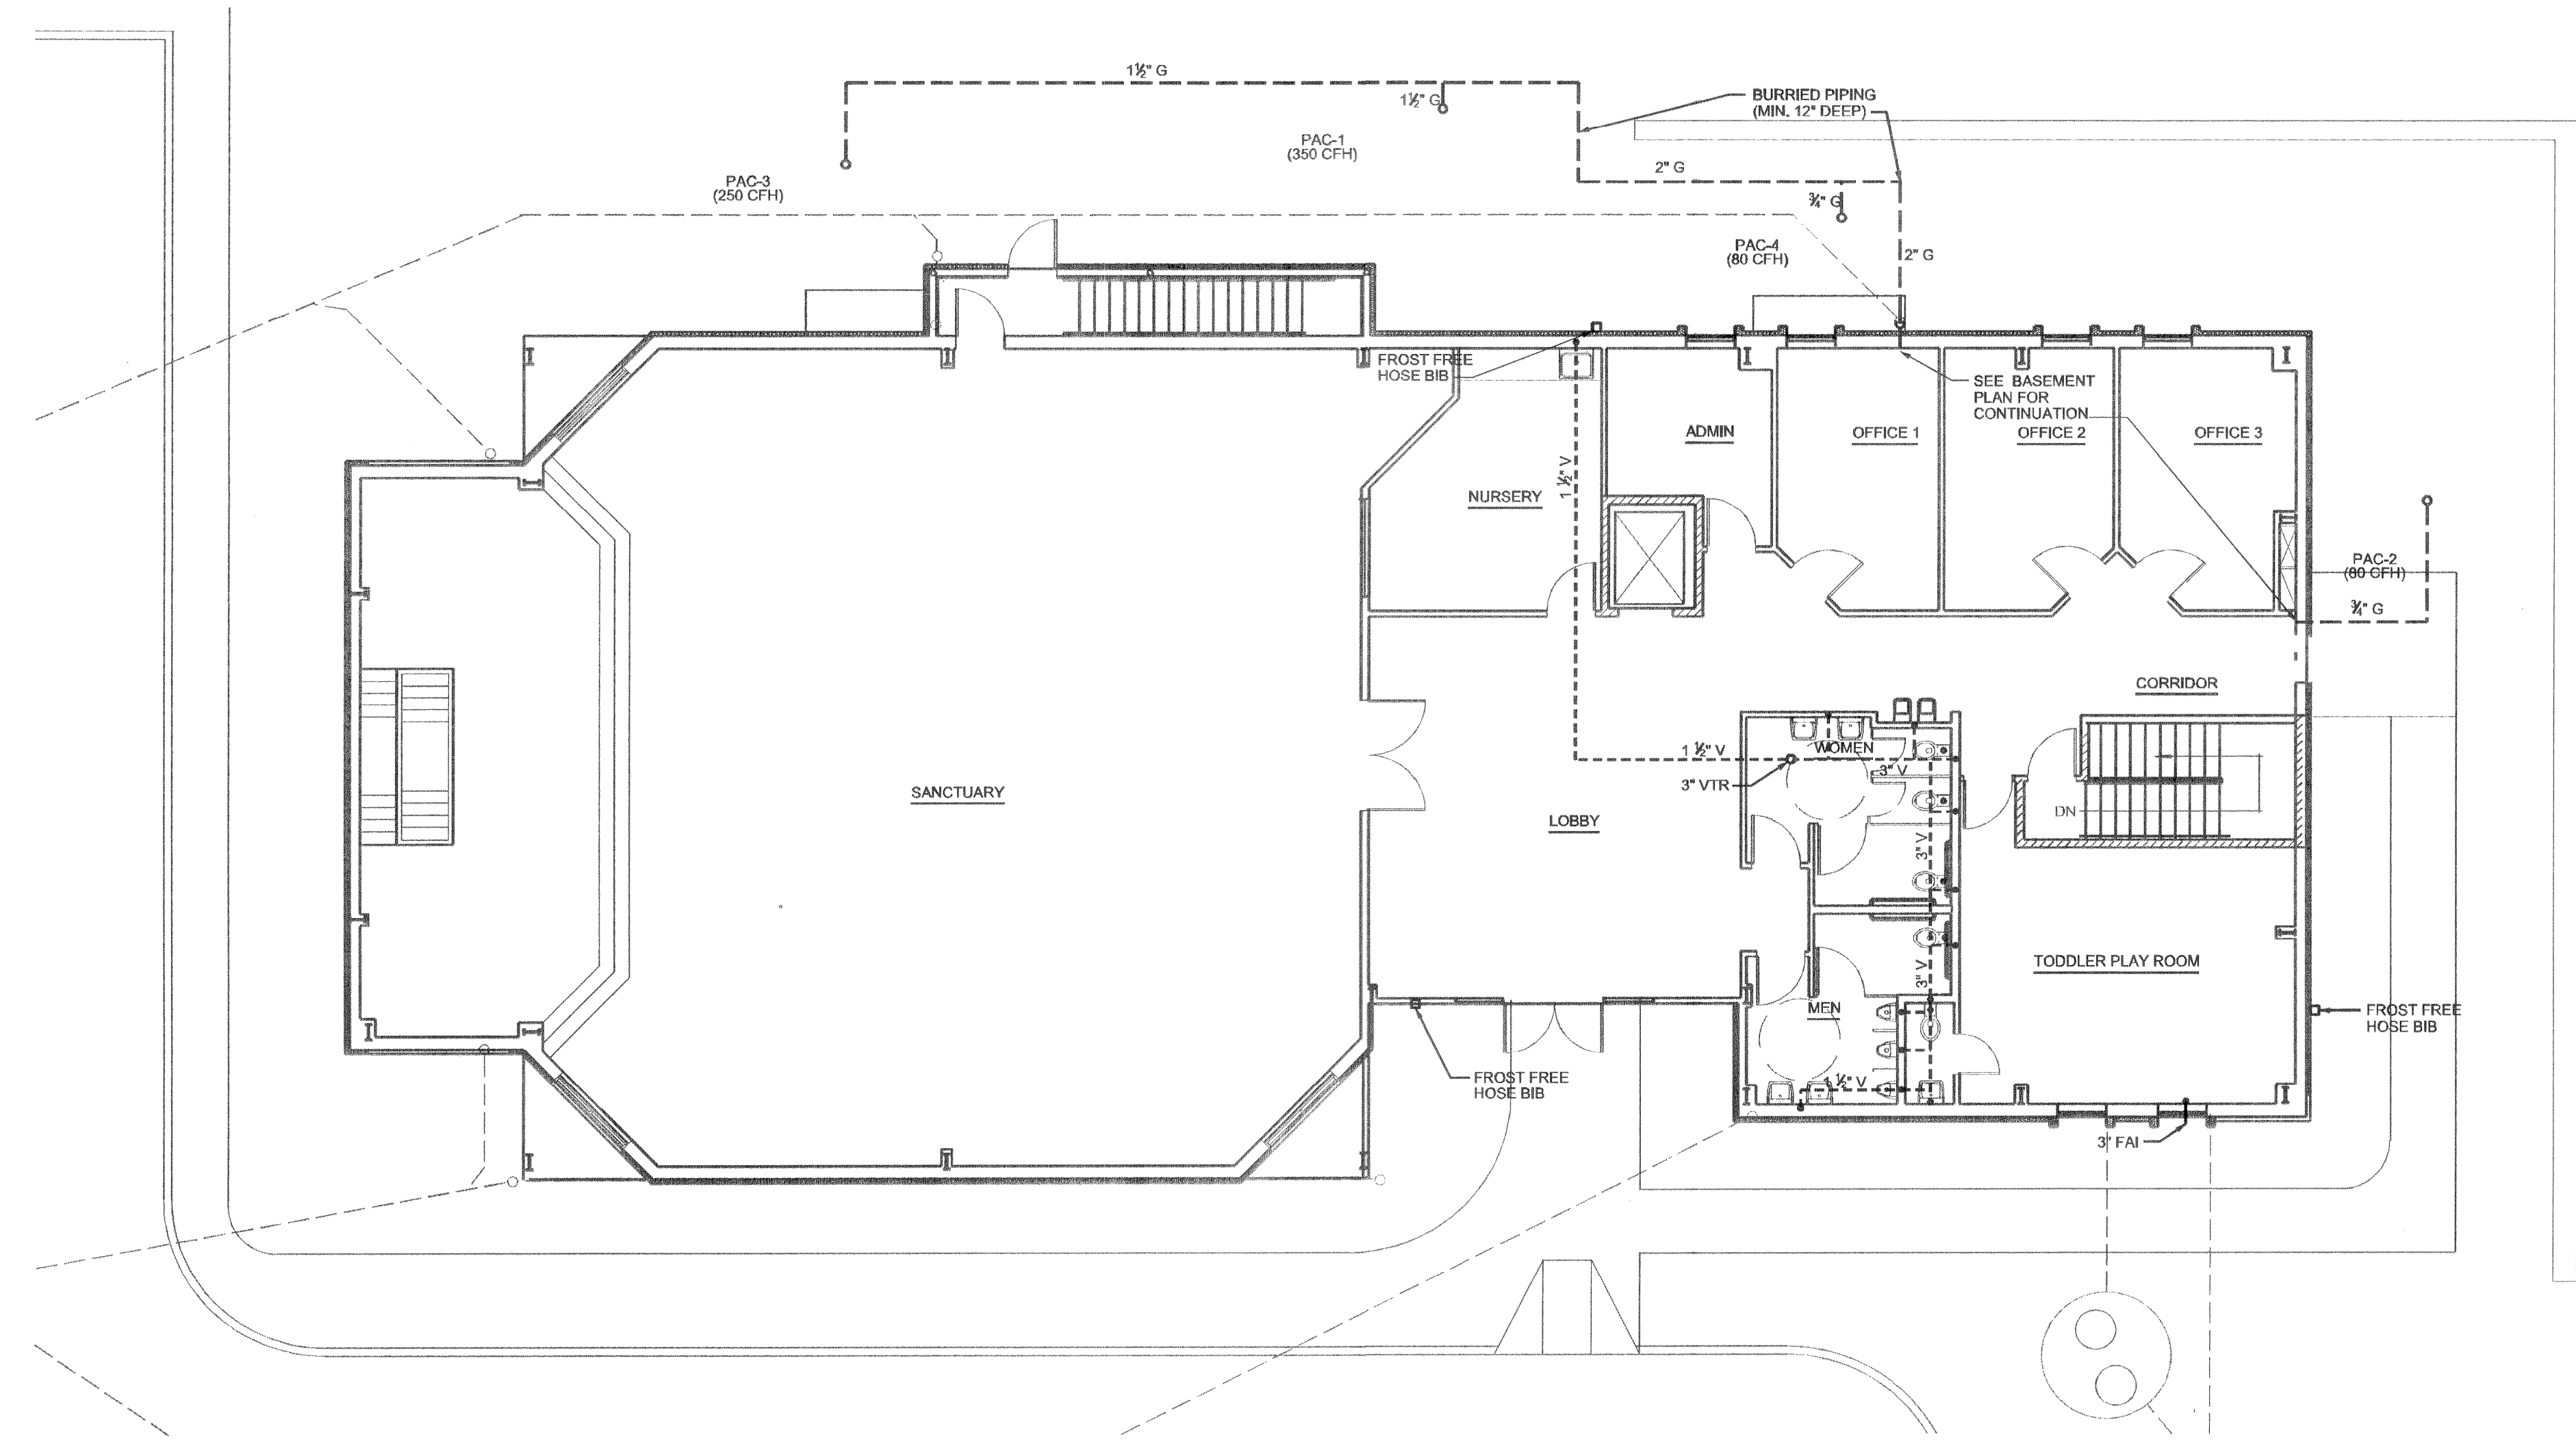

1ST FLOOR PLAN

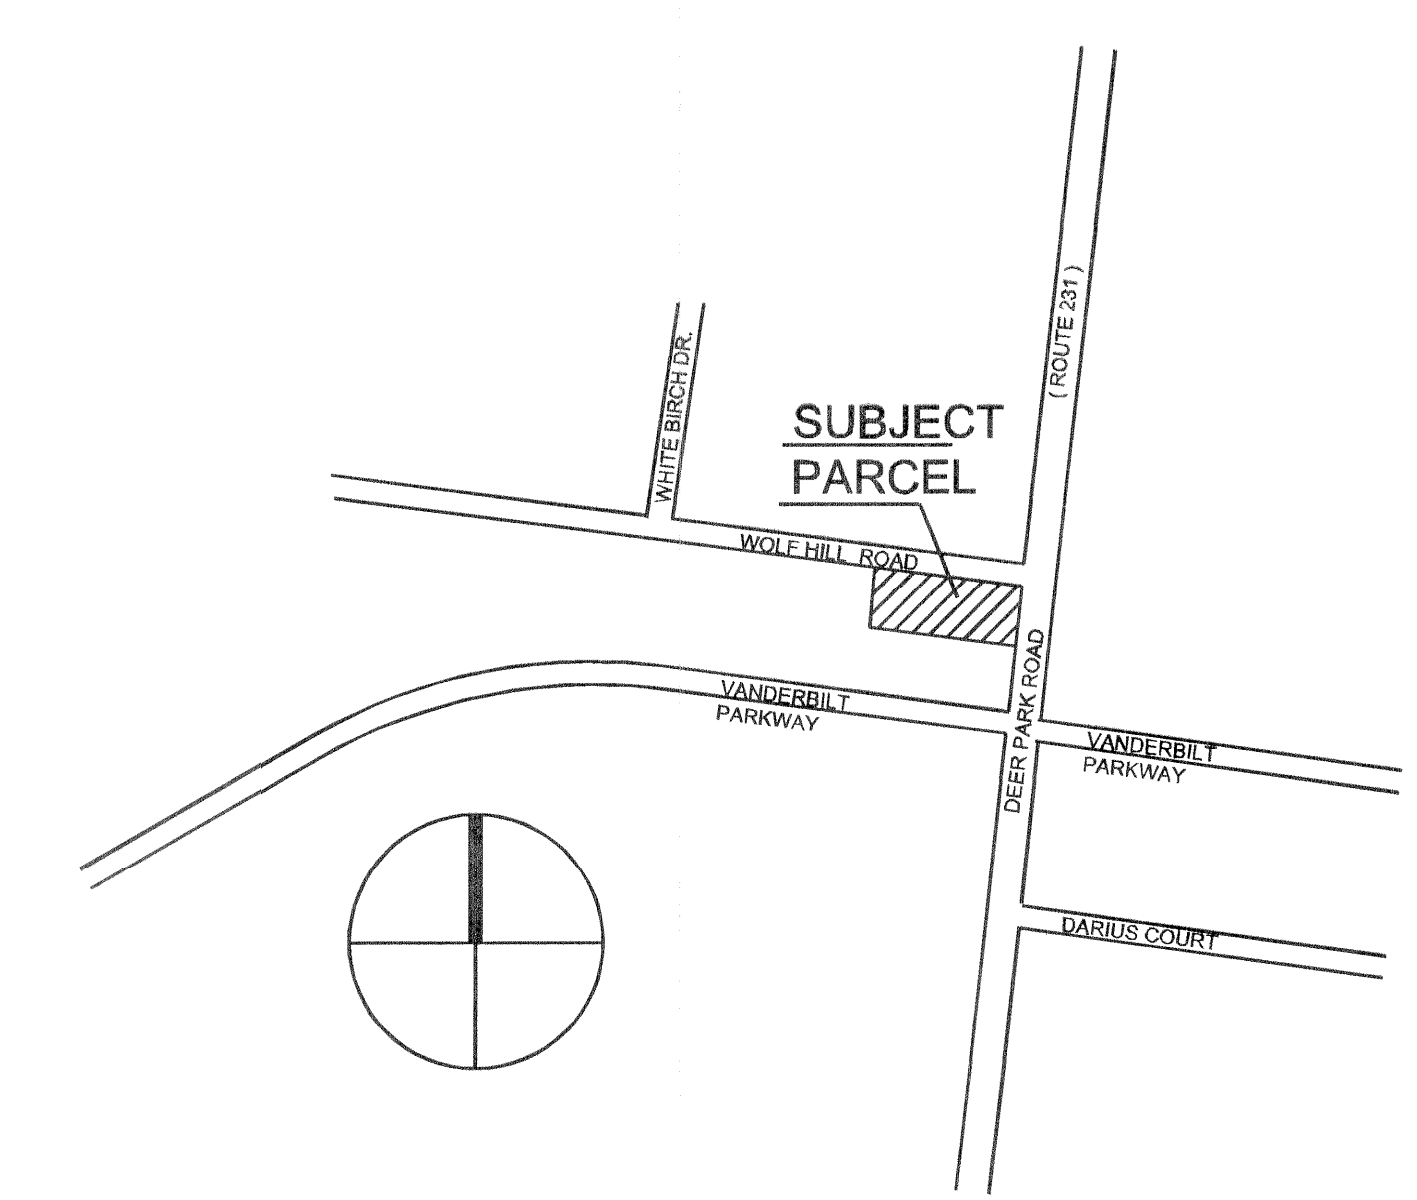

SITE PLAN

REV.	DESCRIPTION	DATE
3	SUBMIT TO DOB	12-21-09
2	REVISED	11-14-09
1	REVISED	10-28-09

FC
FRANK C. GESUALDO
 ARCHITECTS - PLANNERS
 77 FLOWER HILL RD
 HUNTINGTON, NY 11743
 (631) 423-1100 FAX (631) 423-0889

TK ENGINEERING, PLLC
 16 TYRAM STREET
 COMMACK, NY 11725
 T. (631) 774-0844 F. (631) 980-4017
 EMAIL: @info@tk-eng.com

THESE PLANS ARE AN INSTRUMENT OF SERVICE AND ARE THE PROPERTY OF THE ARCHITECT. INFRINGEMENTS WILL BE PROSECUTED.

CONTRACTOR SHALL VERIFY ALL FIELD CONDITIONS AND DIMENSIONS AND BE RESPONSIBLE FOR FIELD FIT AND QUALITY OF WORK. NO ALLOWANCES SHALL BE MADE IN BEHALF OF THE CONTRACTOR FOR ANY ERROR OR NEGLIGENCE ON HIS PART.

PROJECT
LONG ISLAND ALLIANCE CHURCH
 377 DEER PARK AVE.
 DIX HILLS, NY

DRAWING
1ST FLOOR & BASEMENT PLUMBING PLANS

BY **TK** DWG. NO.
 SCALE **1/8"=1'-0"**
 DATE **11-23-08**
 PROJ. NO. **07222**

P1